

SardHy
Green Hydrogen S.r.l.
Stabilimento di Sarroch (Cagliari)



**REALIZZAZIONE DI UN IMPIANTO DI
PRODUZIONE DI IDROGENO VERDE
MEDIANTE ELETTROLISI**

Studio di Impatto Ambientale
D.lgs. 152/2006

Schema elettrico dell'impianto

AM-PL10024

LEGENDA

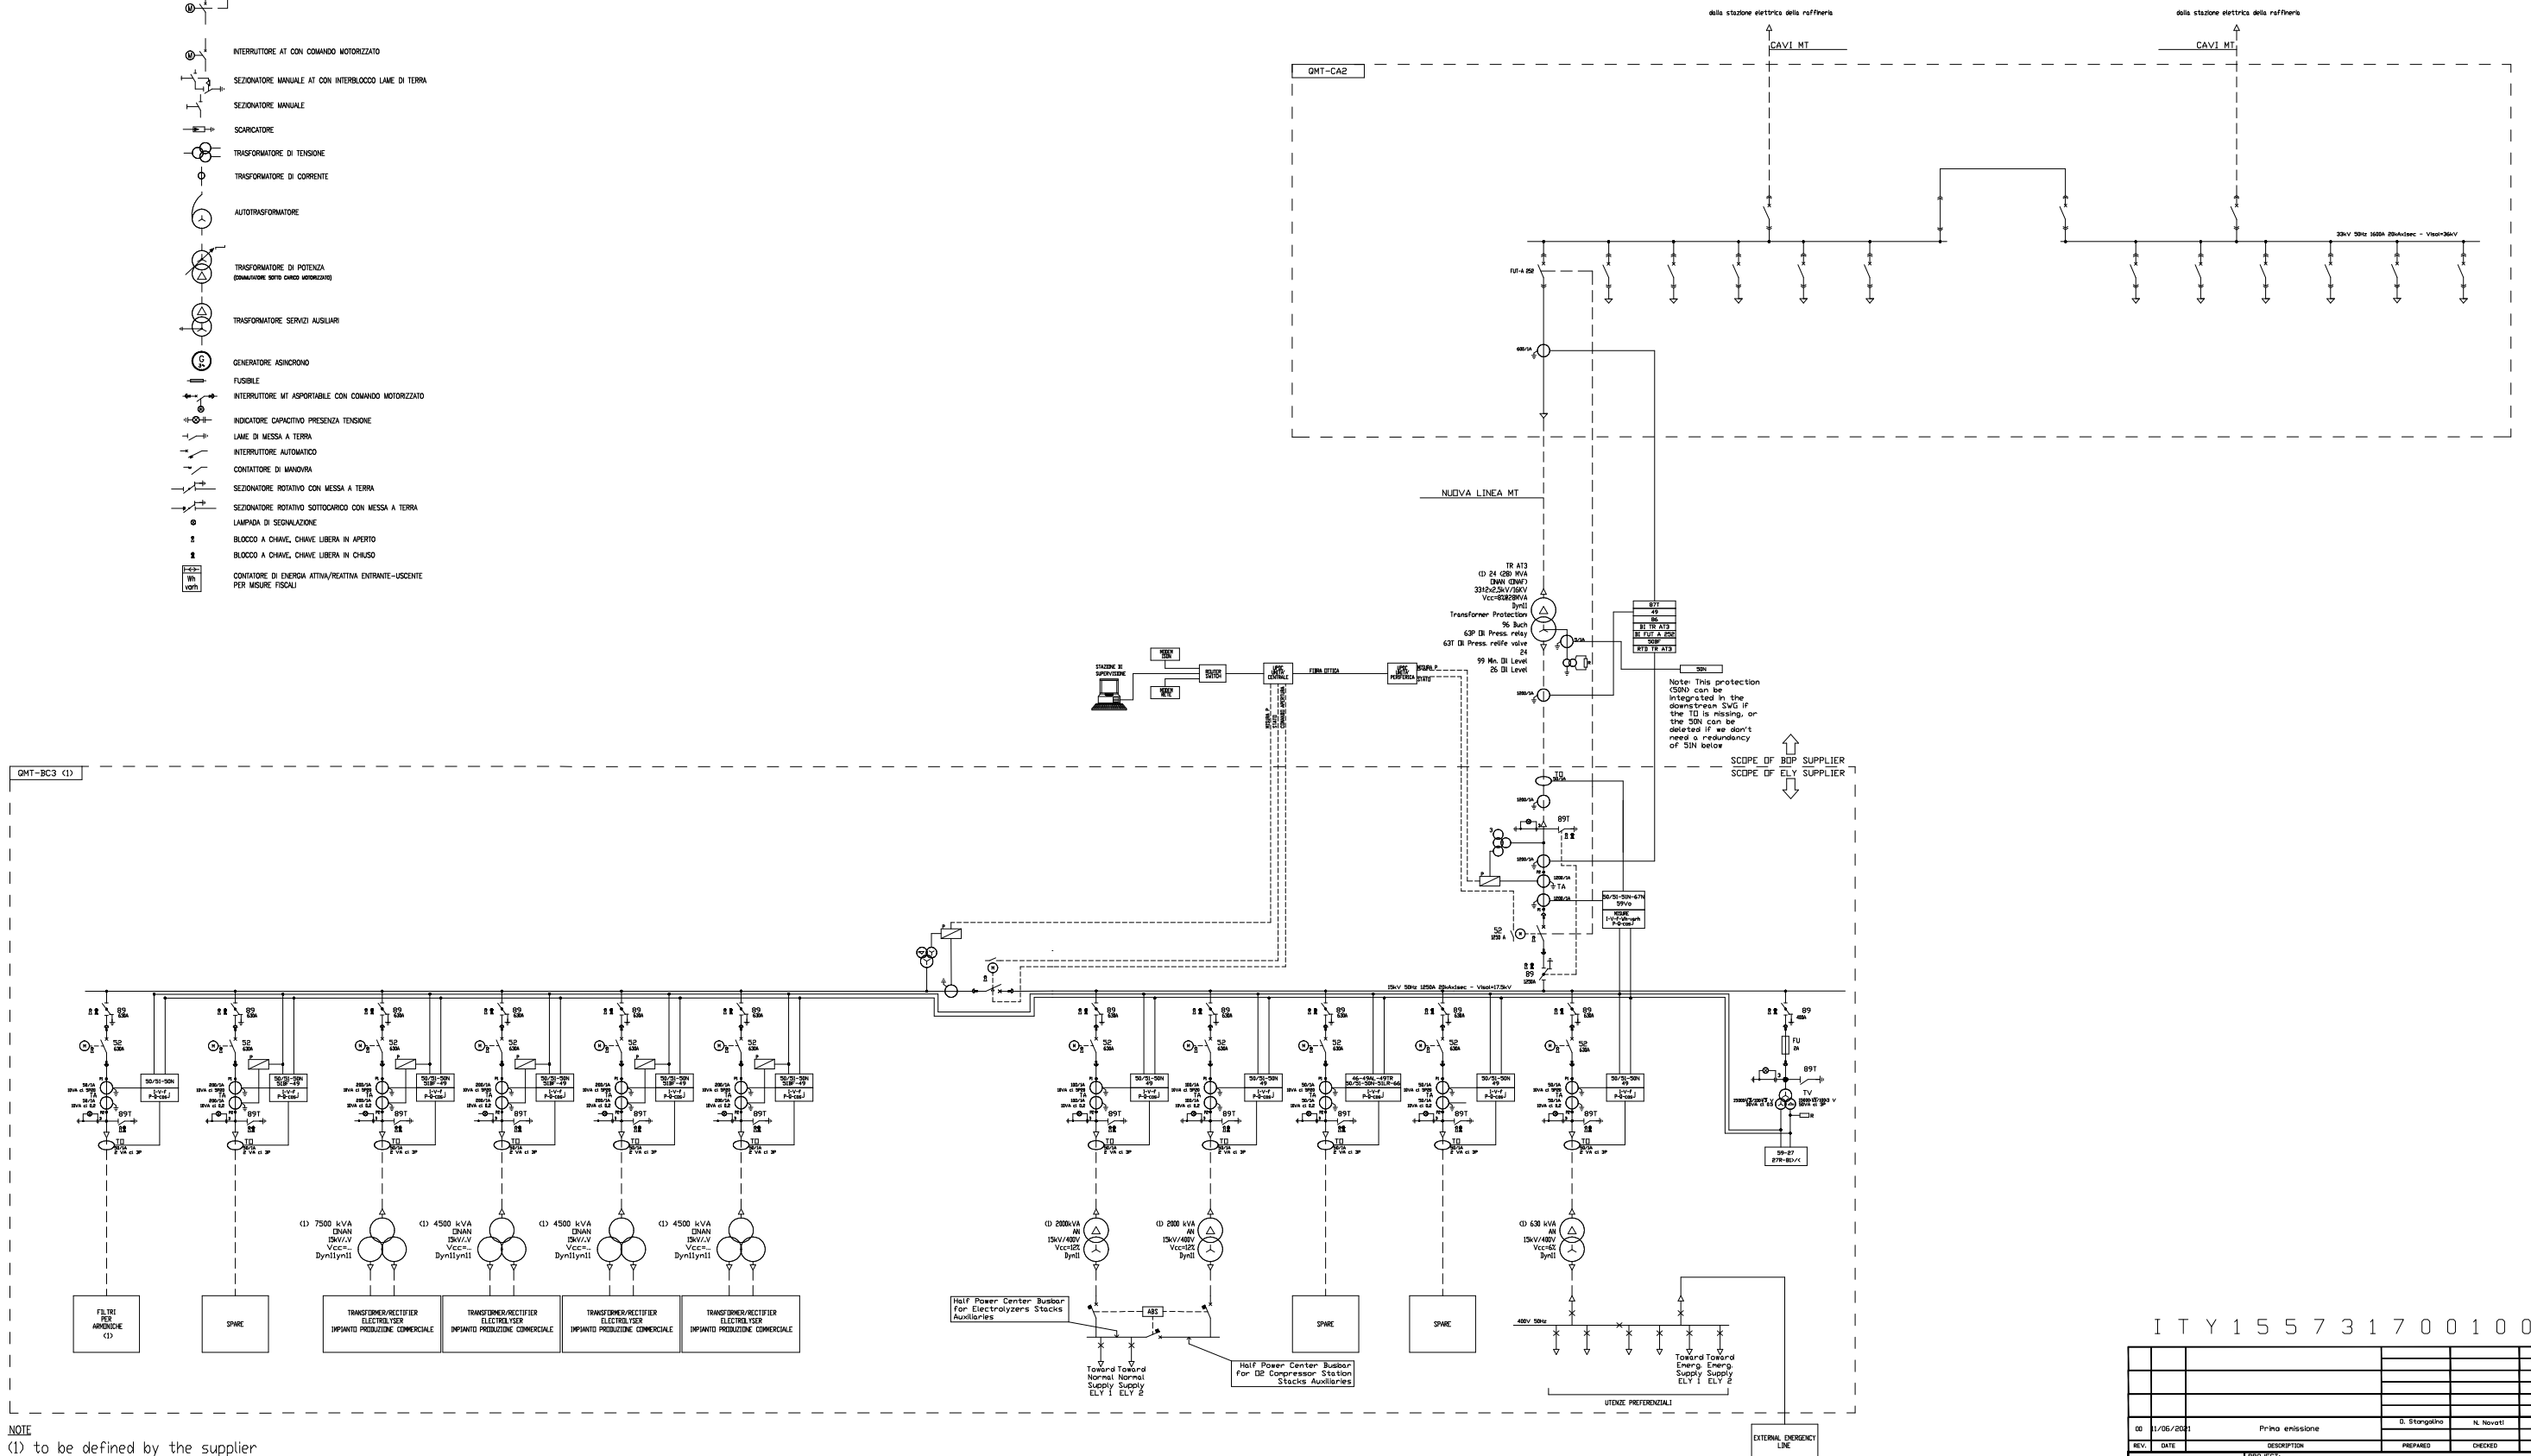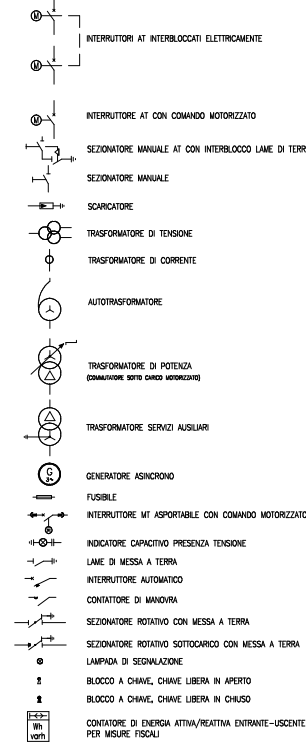

NOTE
 (1) to be defined by the supplier

ITY155731700100

00	11/05/2024	Prima emissione	D. Stangelino	N. Novati	D. Stangelino
REV.	DATE	DESCRIPTION	PREPARED	CHECKED	APPROVED
PROJECT: IMPIANTO DI PRODUZIONE DI IDROGENO DA ELETTROLISI					
FILE NAME: GREEC.D017.155731700100 - Schema unifilare					
CLASSIFICATION		FORMAT: A0	SCALE: -	PLOT SCALE: 1:1	SHEET: 1 di 1
UTILIZATION SCOPE:		TITLE: Schema elettrico unifilare impianto Sarag			
EGP VALIDATION		ENGINEERING & CONSTRUCTION: Richiesta Preventivo per Connessione			
DESIGNED BY: G. De Sgualtero		DRAWN BY: N. Corbelli			
CHECKED BY: N. Corbelli		APPROVED BY: G. De Sgualtero			
COLLABORATOR: N. Corbelli		REVISION: 001			

This document is property of Ener Green Power SpA. It is strictly forbidden to reproduce this document, in whole or in part, and to provide to others any related information without the previous written consent by Ener Green Power SpA.
 To reproduce this document, in whole or in part, and to provide to others any related information without the previous written consent by Ener Green Power SpA.